

USG-PERFORATED GYPSUM CEILING - Q12 (1200mm X 600mm)

USG Middle East

Main Office:
7410 (Wasil), Street #23, Cross 76. 2nd Industrial City
Dammam 34425-4201, Kingdom of Saudi Arabia
+966 13 812 0095

www.usgme.com

Project Name
Title : Project Status
Owner
Architect

Status Study Execution Installation

Examined and approved by the customer

Scale : as shown

Reference-Drawing :

Created : /
Checked : /
Drawing : Revision: 1

Revised

©2020 Factory of USG Middle East LTD. Co. All rights reserved.
FACTORY OF USG MIDDLE EAST reserves all rights to the information disclosed in this drawing. Such information may not be copied nor forwarded in any other form to third parties without the express consent in writing of Factory USG Middle East for the purpose of manufacture or purchase of the products or parts shown.

Final revision to be issued and approved by USG ME Technical Team

General Notes:

Client Stamp:


Client Logos

Project Date:


Drawing Number:

Q12


Scale : as shown

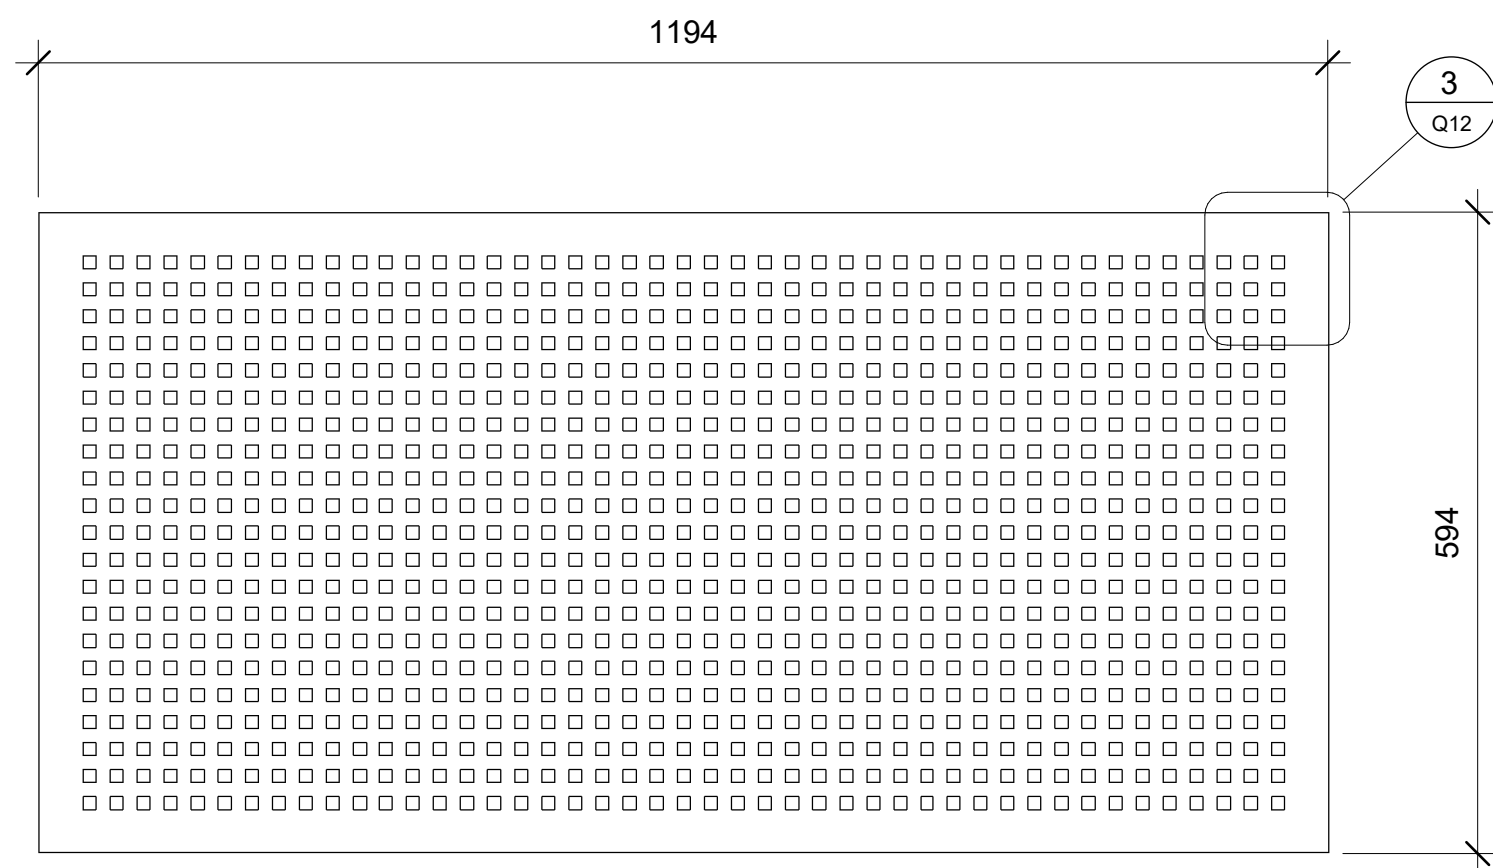


1 Plan
1 : 7

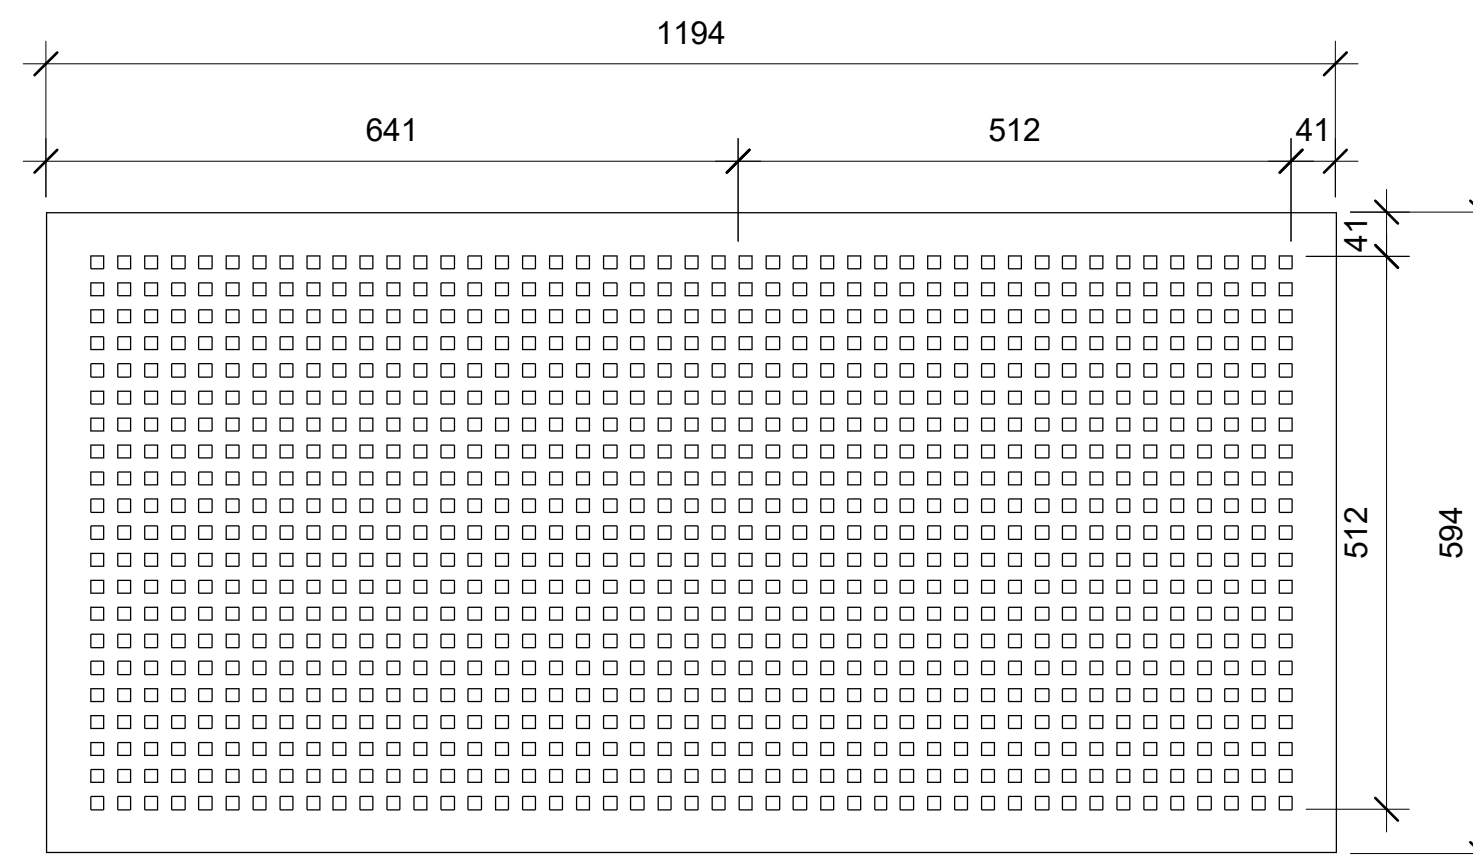

2 Reflected Ceiling Plan
1 : 7

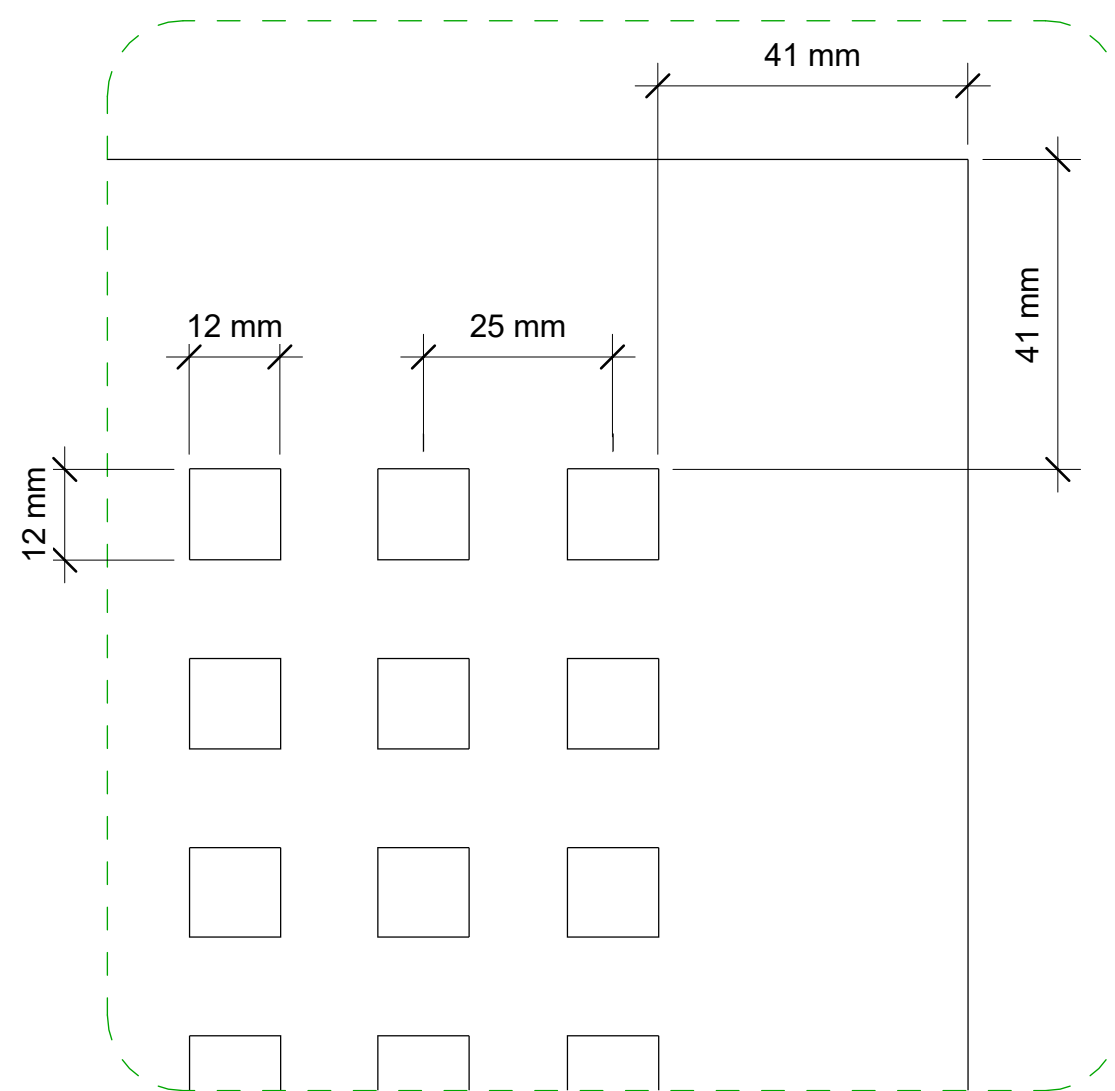

3 Detail 1
1 : 1

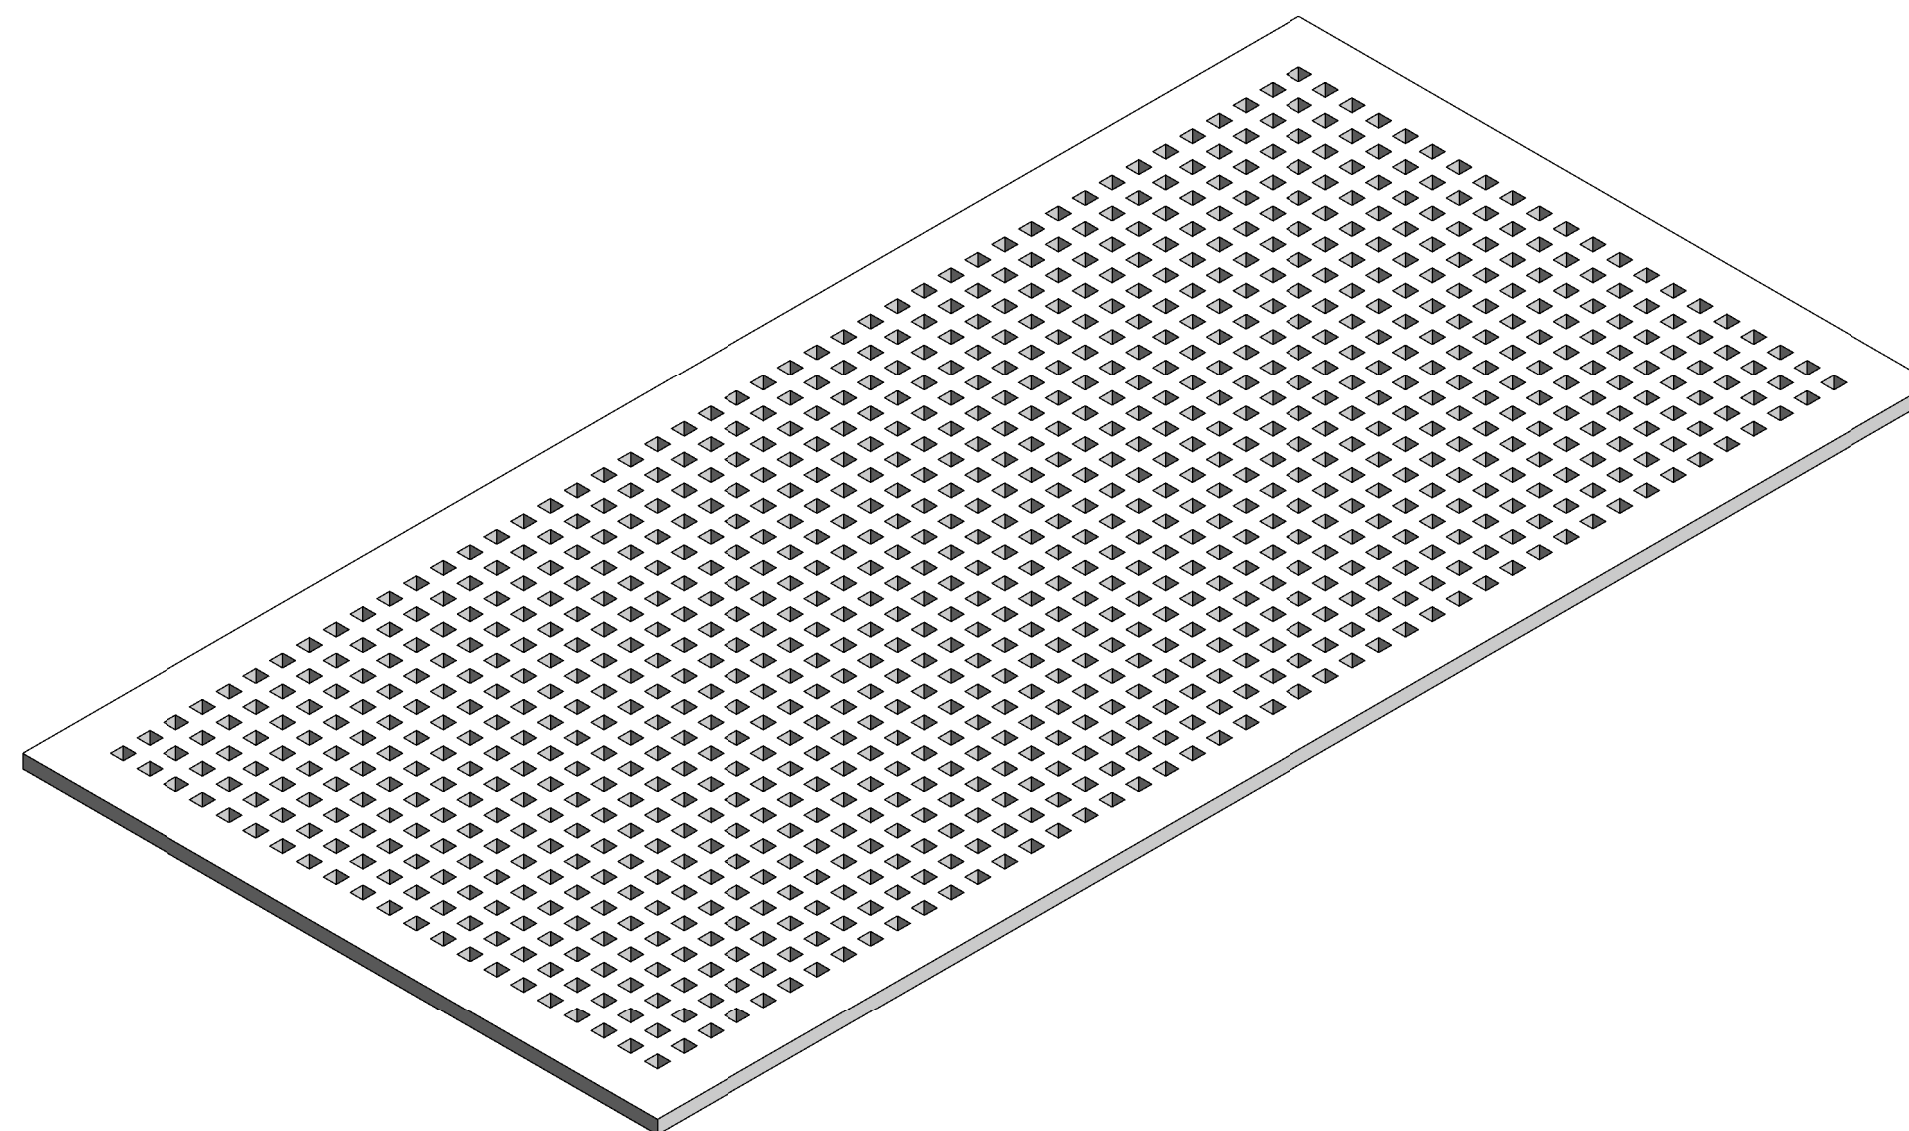

4 Isometric View